



SECTION A-A

**GENERAL NOTES**  
 1. DUCTING TO SIT BETWEEN ROOF LEVELS, HIDDEN FROM PUBLIC VIEW.  
 2. ALL FILTERS & SILENCERS WILL MEET RECOMENDED GUIDELINES.  
 3. ALL PAPERWORK WILL BE SUPPLIED WITH INFORMATION.

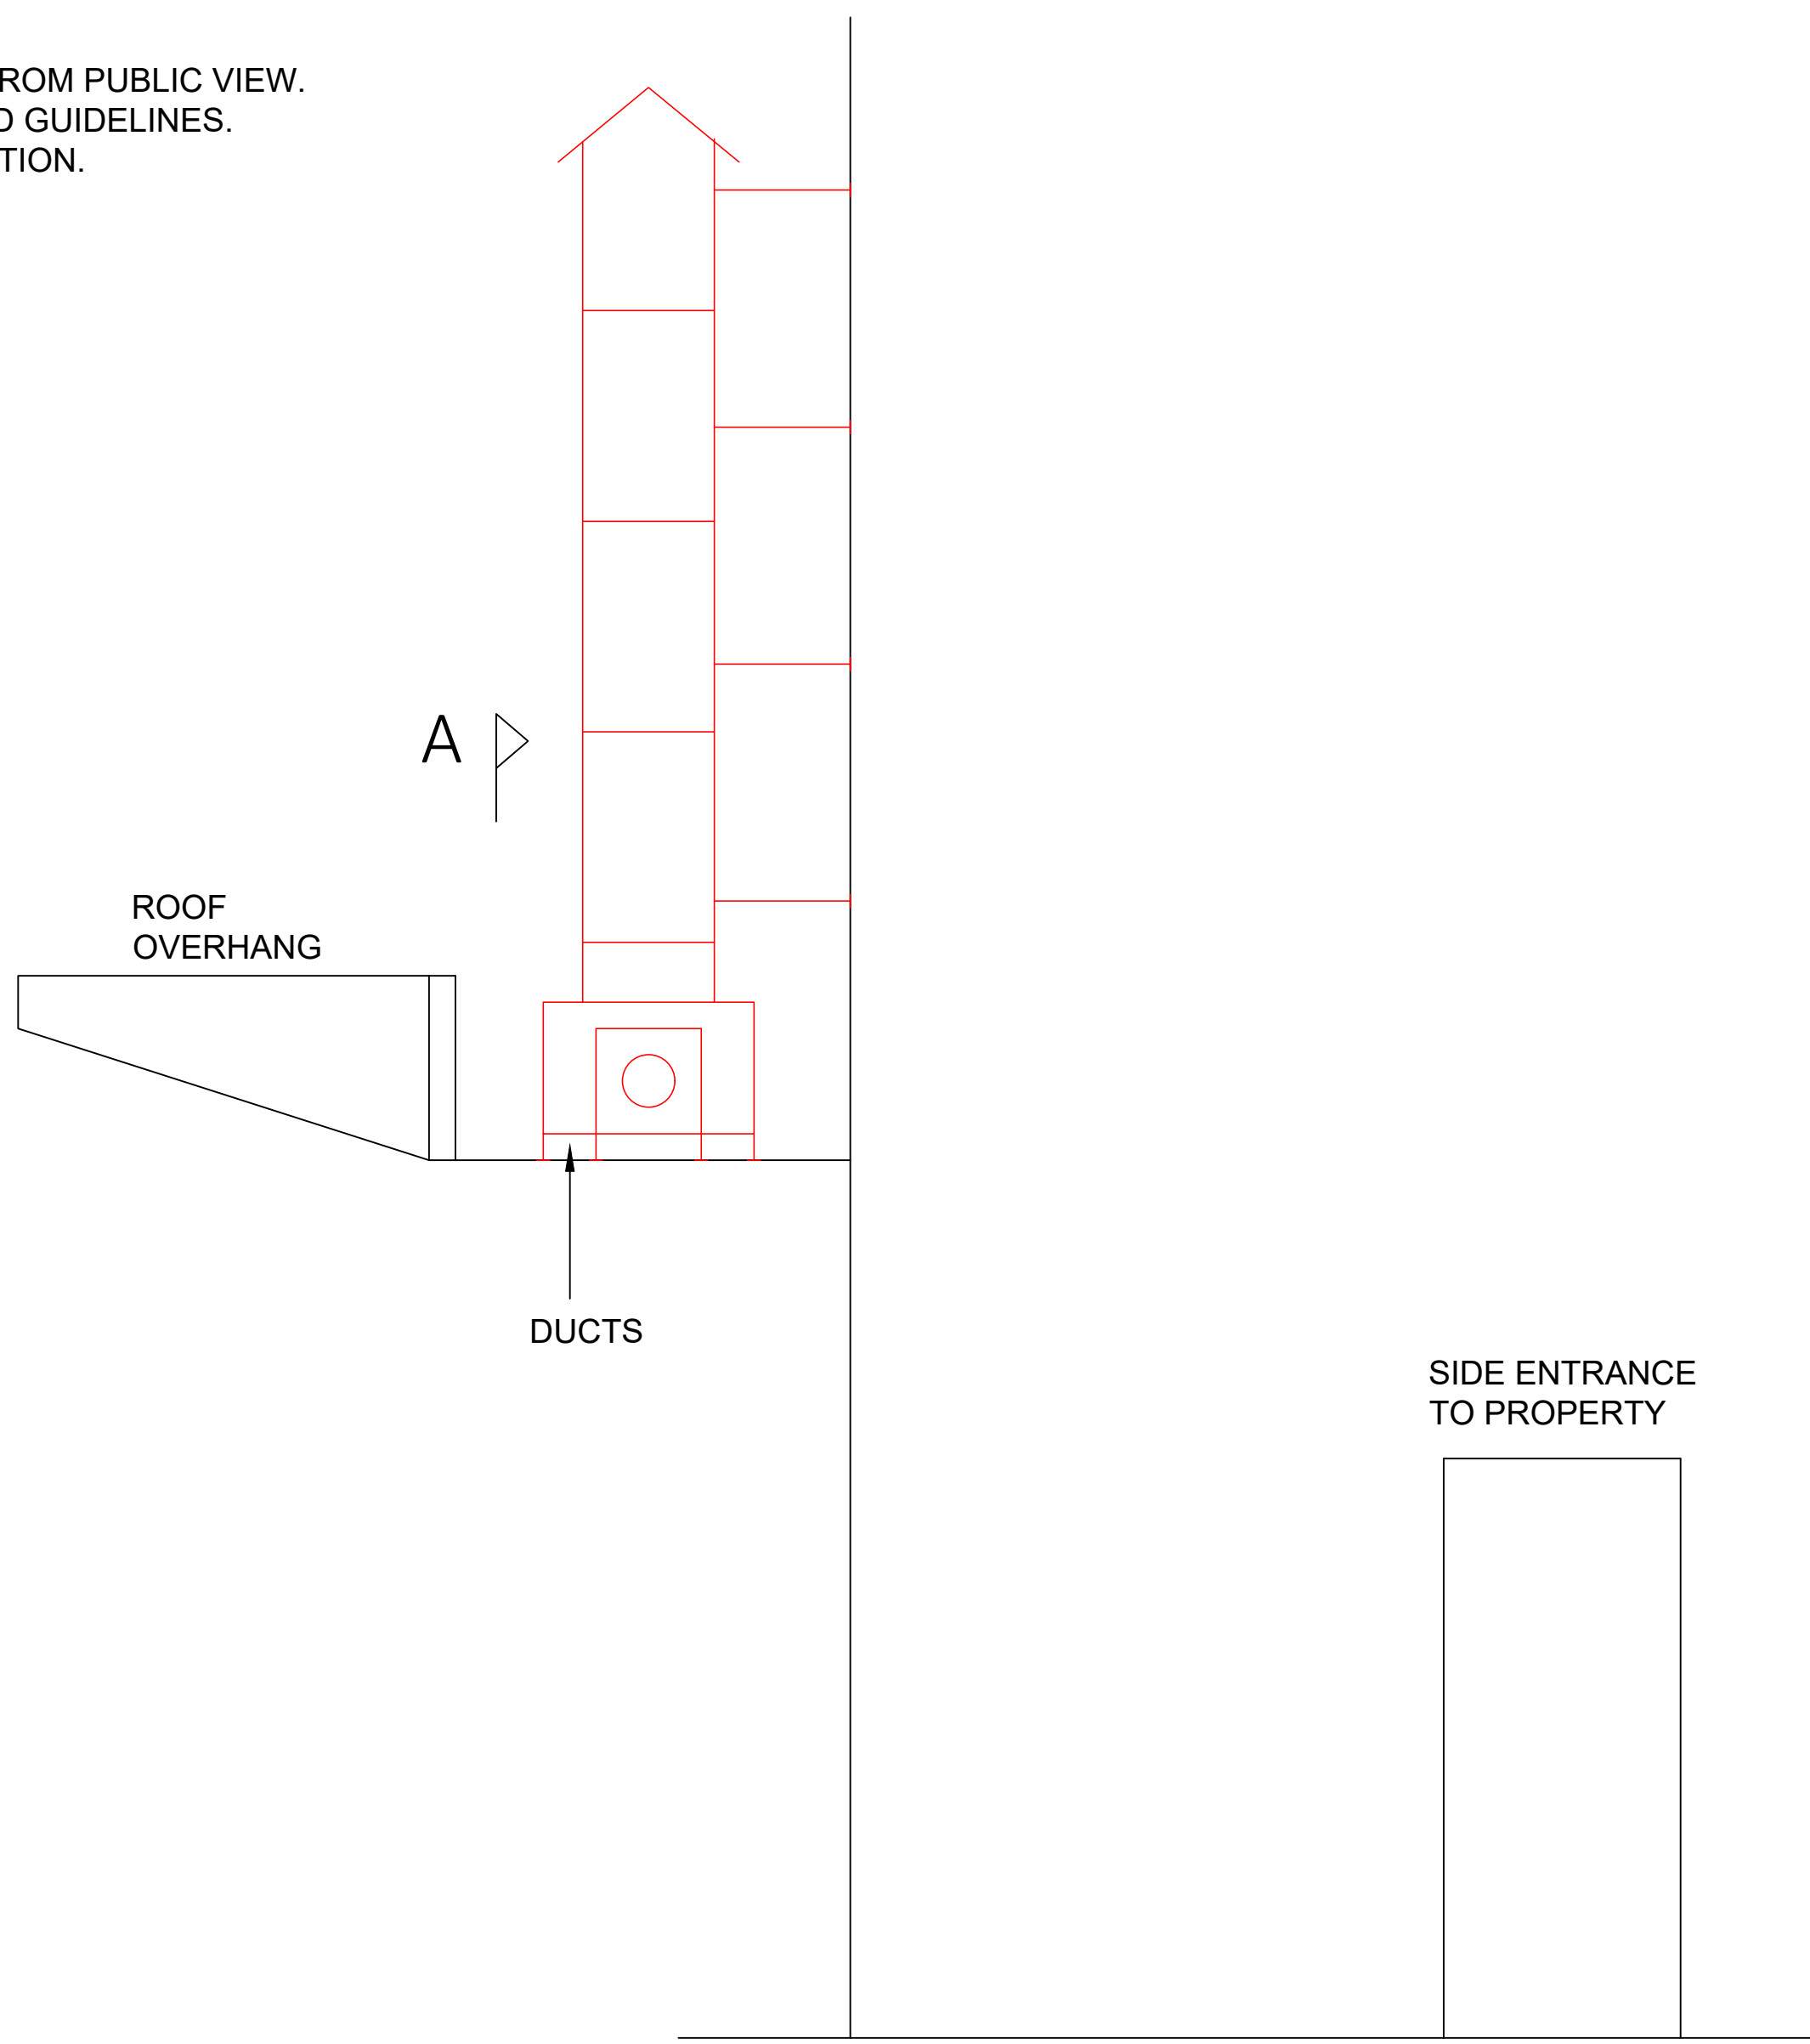

A

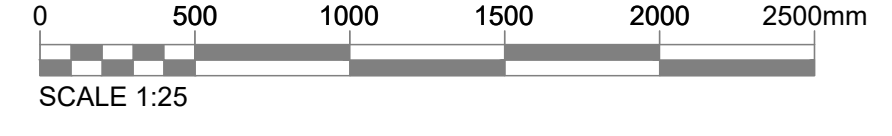

**REVISIONS**

|   |                  |            |
|---|------------------|------------|
| C | UPDATED          | 10.01.2024 |
| B | DUCTWORK UPDATED | 17.11.2023 |
| A | FOR REVIEW       | 29.10.2021 |

THIS DRAWING IS THE PROPERTY OF AIRCONDITIONING SOUTH WEST LIMITED AT ALL TIMES IT MUST NOT BE COPIED OR PASSED TO A THIRD PARTY WITHOUT WRITTEN CONSENT.

FIGURED DIMENSIONS TO BE READ IN PREFERENCE TO SCALED

CLIENT  
 KEBAB ROYAL

PROJECT  
 2 HILLVIEW ROAD  
 HUCCLECOTE  
 GLOUCESTER  
 GL3 3LD

DRAWING TITLE  
 PROPOSED VENTILATION LAYOUT

|             |           |          |           |
|-------------|-----------|----------|-----------|
| DATE        | OCT 2021  | CAD REF  | C07721    |
| DRAWING NO. | C07721-01 | REVISION | C         |
| SCALE       | 1:50@A1   | DRAWN BY | MAS (CJS) |



Telephone: (01452) 721240  
 E Mail: andy@acsw.co.uk  
 www.acsw.co.uk